



NOTES

1. THIS DRAWING IS TO BE READ IN CONJUNCTION WITH ALL ENGINEERS & ARCHITECTS DRAWINGS FIGURED DIMENSIONS ONLY (NOT SCALING) TO BE USED. WHERE A CONFLICT OF INFORMATION EXISTS OR IF IN ANY DOUBT - 'ASK'.
2. CONSULTANTS TO BE INFORMED IMMEDIATELY OF ANY DISCREPANCIES BEFORE WORK PROCEEDS.

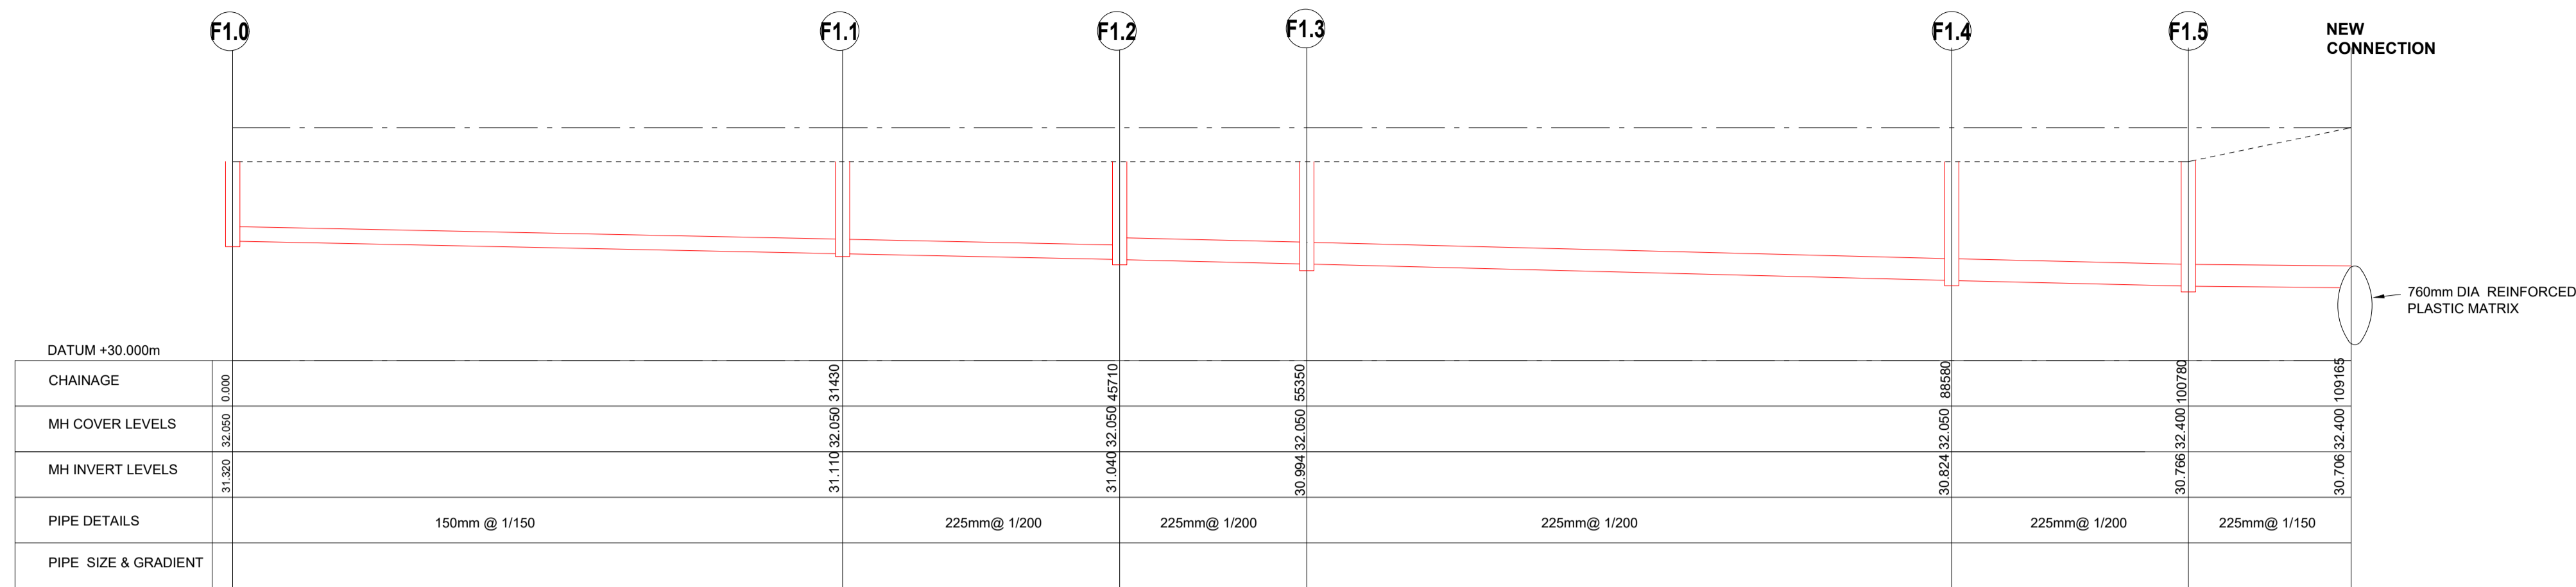


LONGITUDINAL SECTION F1.0 TO F1.4

HORIZONTAL SCALE @ A1: 1:250
 VERTICAL SCALE @ A1: 1:50
 HORIZONTAL SCALE @ A3: 1:500
 VERTICAL SCALE @ A3: 1:100

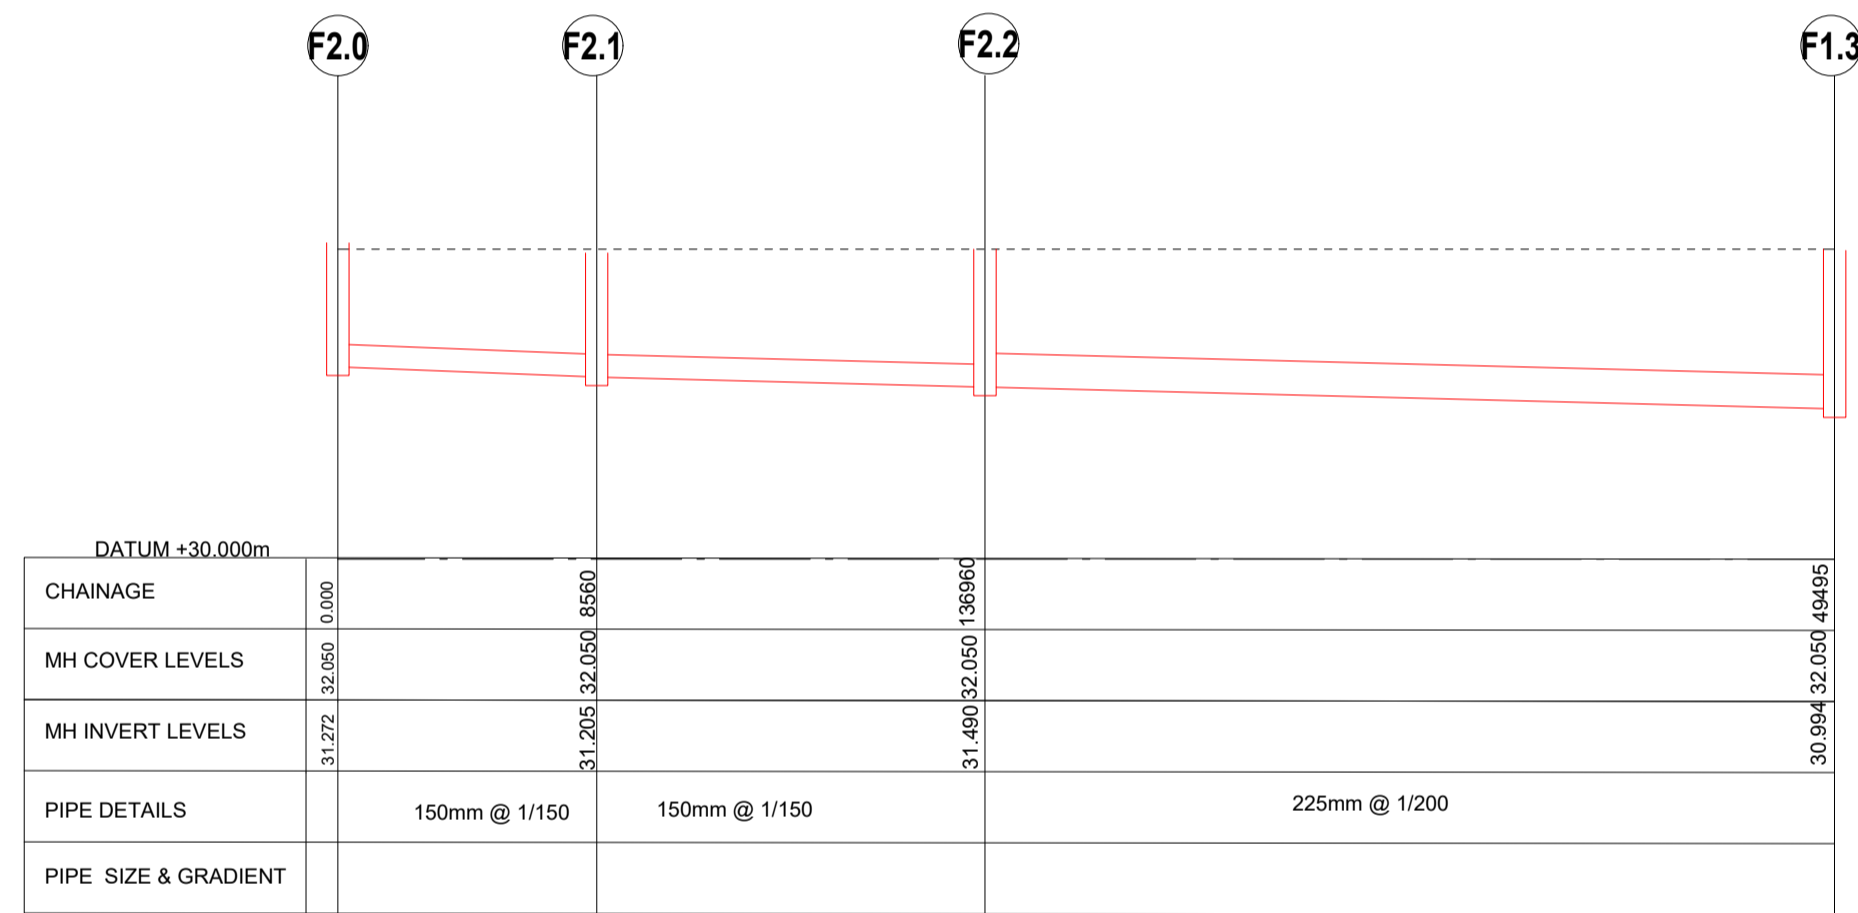


LONGITUDINAL SECTION F2.0 TO F1.3

HORIZONTAL SCALE @ A1: 1:250
 VERTICAL SCALE @ A1: 1:50
 HORIZONTAL SCALE @ A3: 1:500
 VERTICAL SCALE @ A3: 1:100

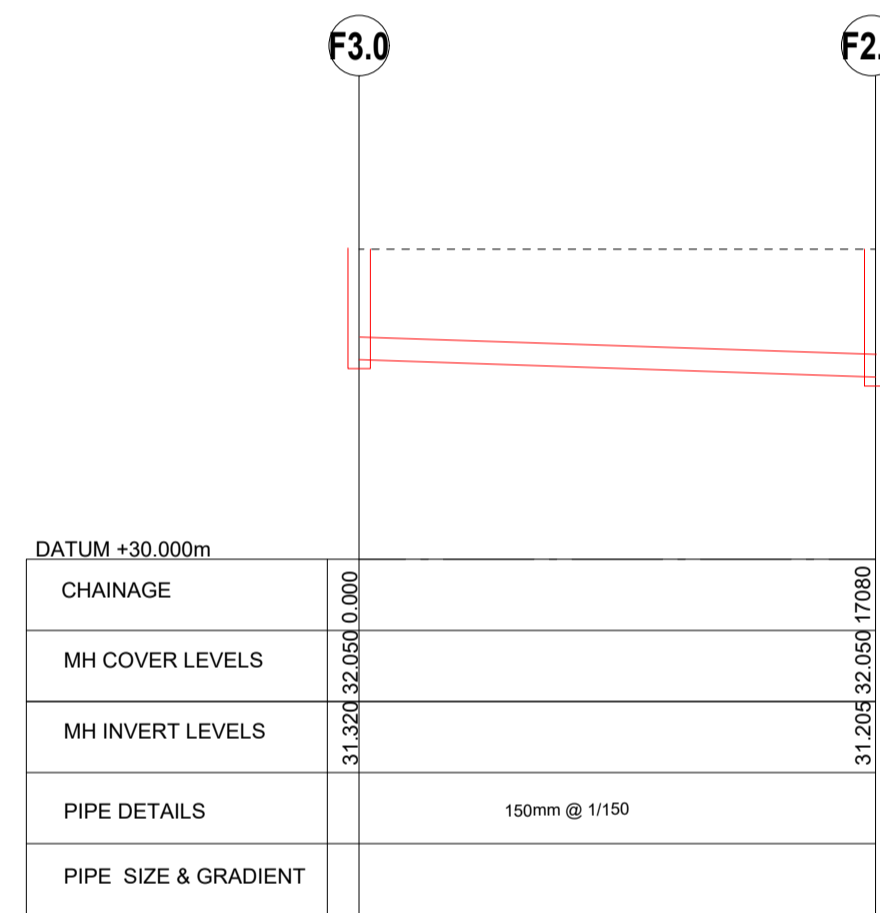

LONGITUDINAL SECTION F3.0 TO F2.1

HORIZONTAL SCALE @ A1: 1:250
 VERTICAL SCALE @ A1: 1:50
 HORIZONTAL SCALE @ A3: 1:500
 VERTICAL SCALE @ A3: 1:100

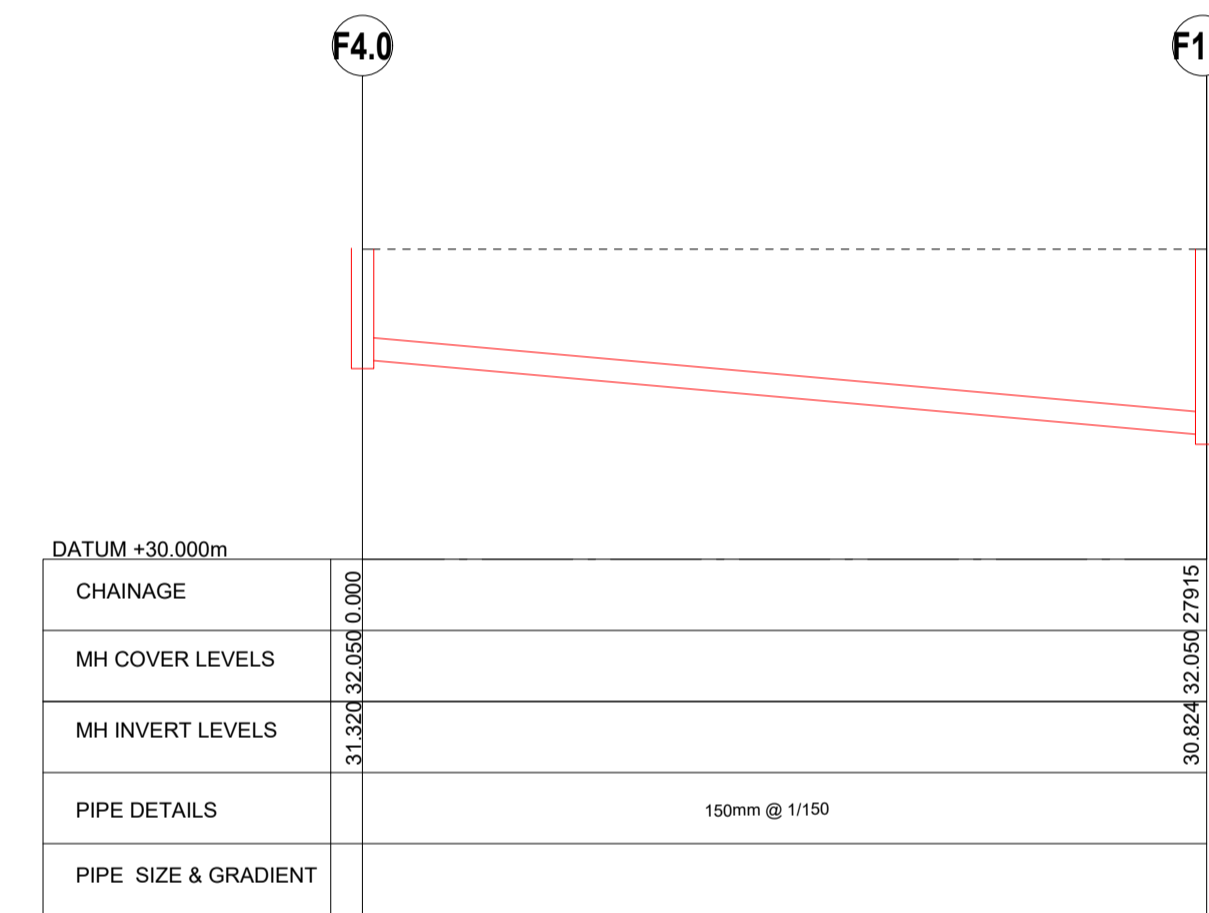

LONGITUDINAL SECTION F4.0 TO F2.1

HORIZONTAL SCALE @ A1: 1:250
 VERTICAL SCALE @ A1: 1:50
 HORIZONTAL SCALE @ A3: 1:500
 VERTICAL SCALE @ A3: 1:100

PL3	18.02.20	ISSUED FOR PLANNING	TMG	BMCA	BM
PL2	21.10.19	REVISED AS PER IW COMMENTS	MC	BMCA	BM
PL1	11.10.19	ISSUED TO IRISH WATER	MC	BMCA	BM
ISSUE	DATE	DESCRIPTION	DRN	P.E.	P.D.
			ORIG		

DRAWING STAGE: **PLANNING**

BM Dublin Office:
 Sandwith House, 52-54 Lower Sandwith Street, Dublin 2, Ireland.
 Tel: (01) 677 3200 Fax: (01) 677 3164

London Office:
 12 Mill Street, London SE1 2AY, United Kingdom
 Tel: (0044) 084 5413 2722

Consulting Engineers, Civil, Structural, Project Management. E-mail: bmce@bmce.ie Web: www.bmce.ie



CLIENT: **TRINITY COLLEGE DUBLIN**

PROJECT TITLE	BM PROJECT No.
CUNNINGHAM HOUSE REDEVELOPMENT	19114
MODEL REFERENCE	MODEL REV. SUITABILITY
19114-C-1000	P1 S01

DRAWING TITLE: **PROPOSED DRAINAGE LAYOUT - LONGITUDINAL SECTION**

DRAWING No. **DSR-BMD-ZZ-XX-DR-C-CP-1100** ISSUE **PL3**